



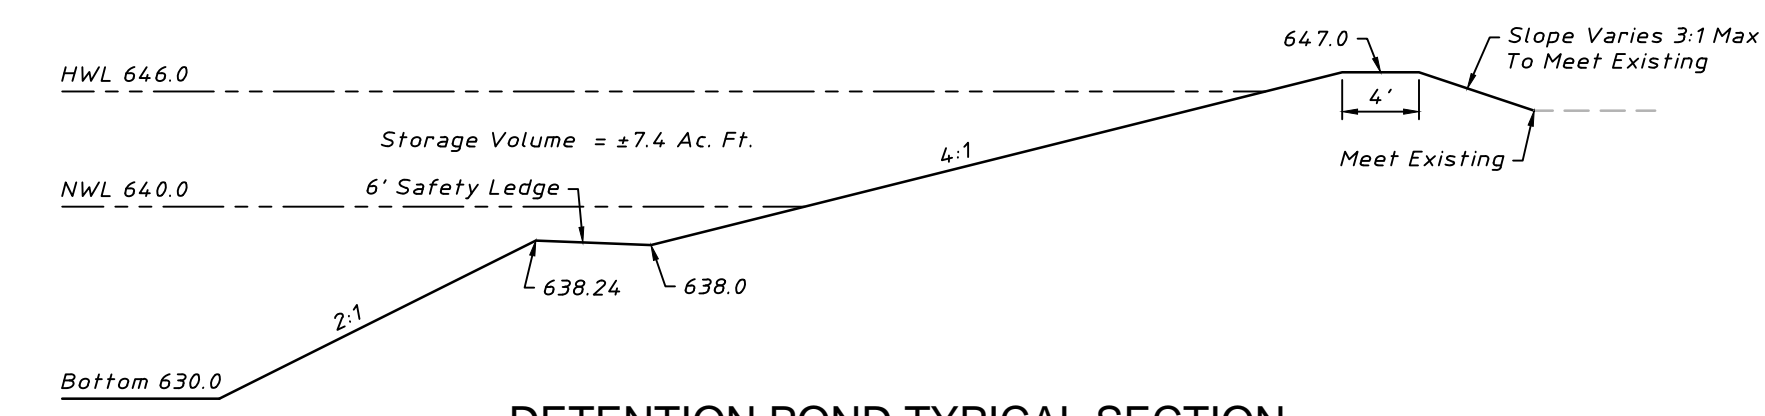

Scale: 1" = 50'

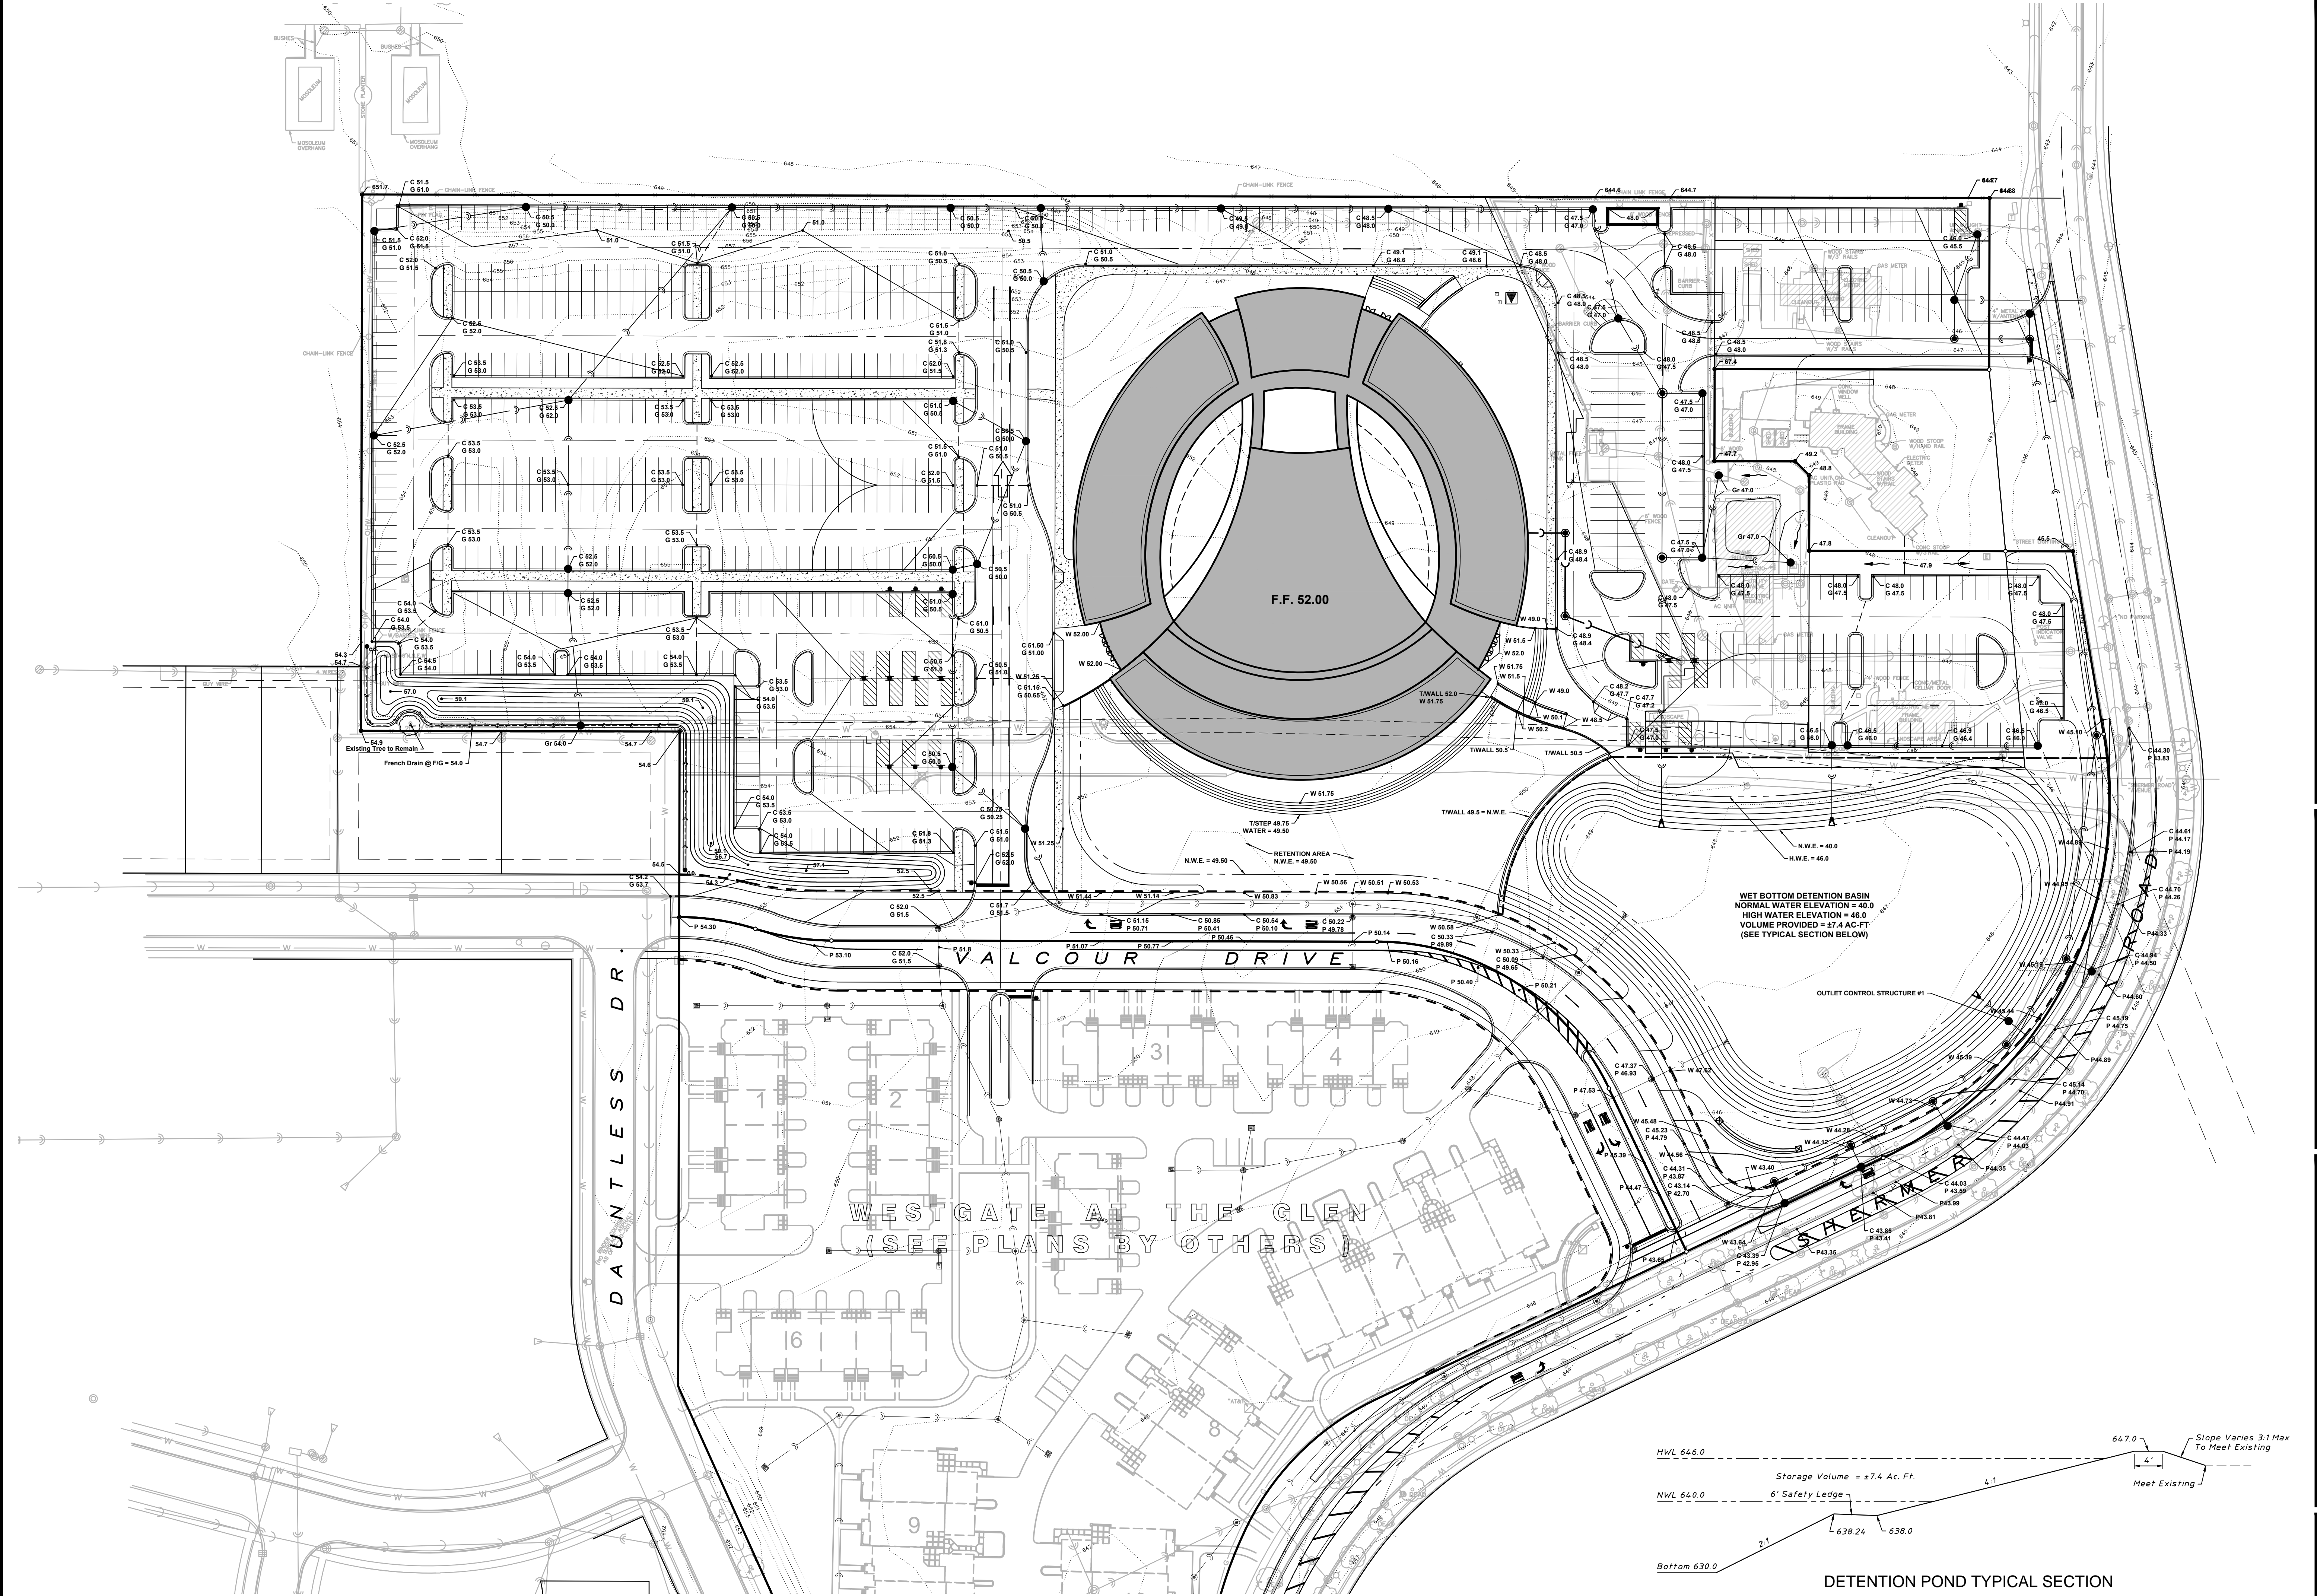

DETENTION POND TYPICAL SECTION


HAEGER ENGINEERING
consulting engineers • land surveyors
1304 N. Plum Grove Road, Schaumburg, IL 60173 • Tel: 847.394.6600 Fax: 847.394.6608
Illinois Professional Design Firm License No. 184-003152
www.haegerengineering.com

CONCEPT ENGINEERING
GRADING PLAN
WILLOW CREEK COMMUNITY
CHURCH NORTH SHORE
GLENVIEW, ILLINOIS

Project Manager: T A S
Engineer: L A K
Date: 09/20/2013
Project No. 13012
Sheet **CE.1** / CE.2



Scale: 1" = 50'


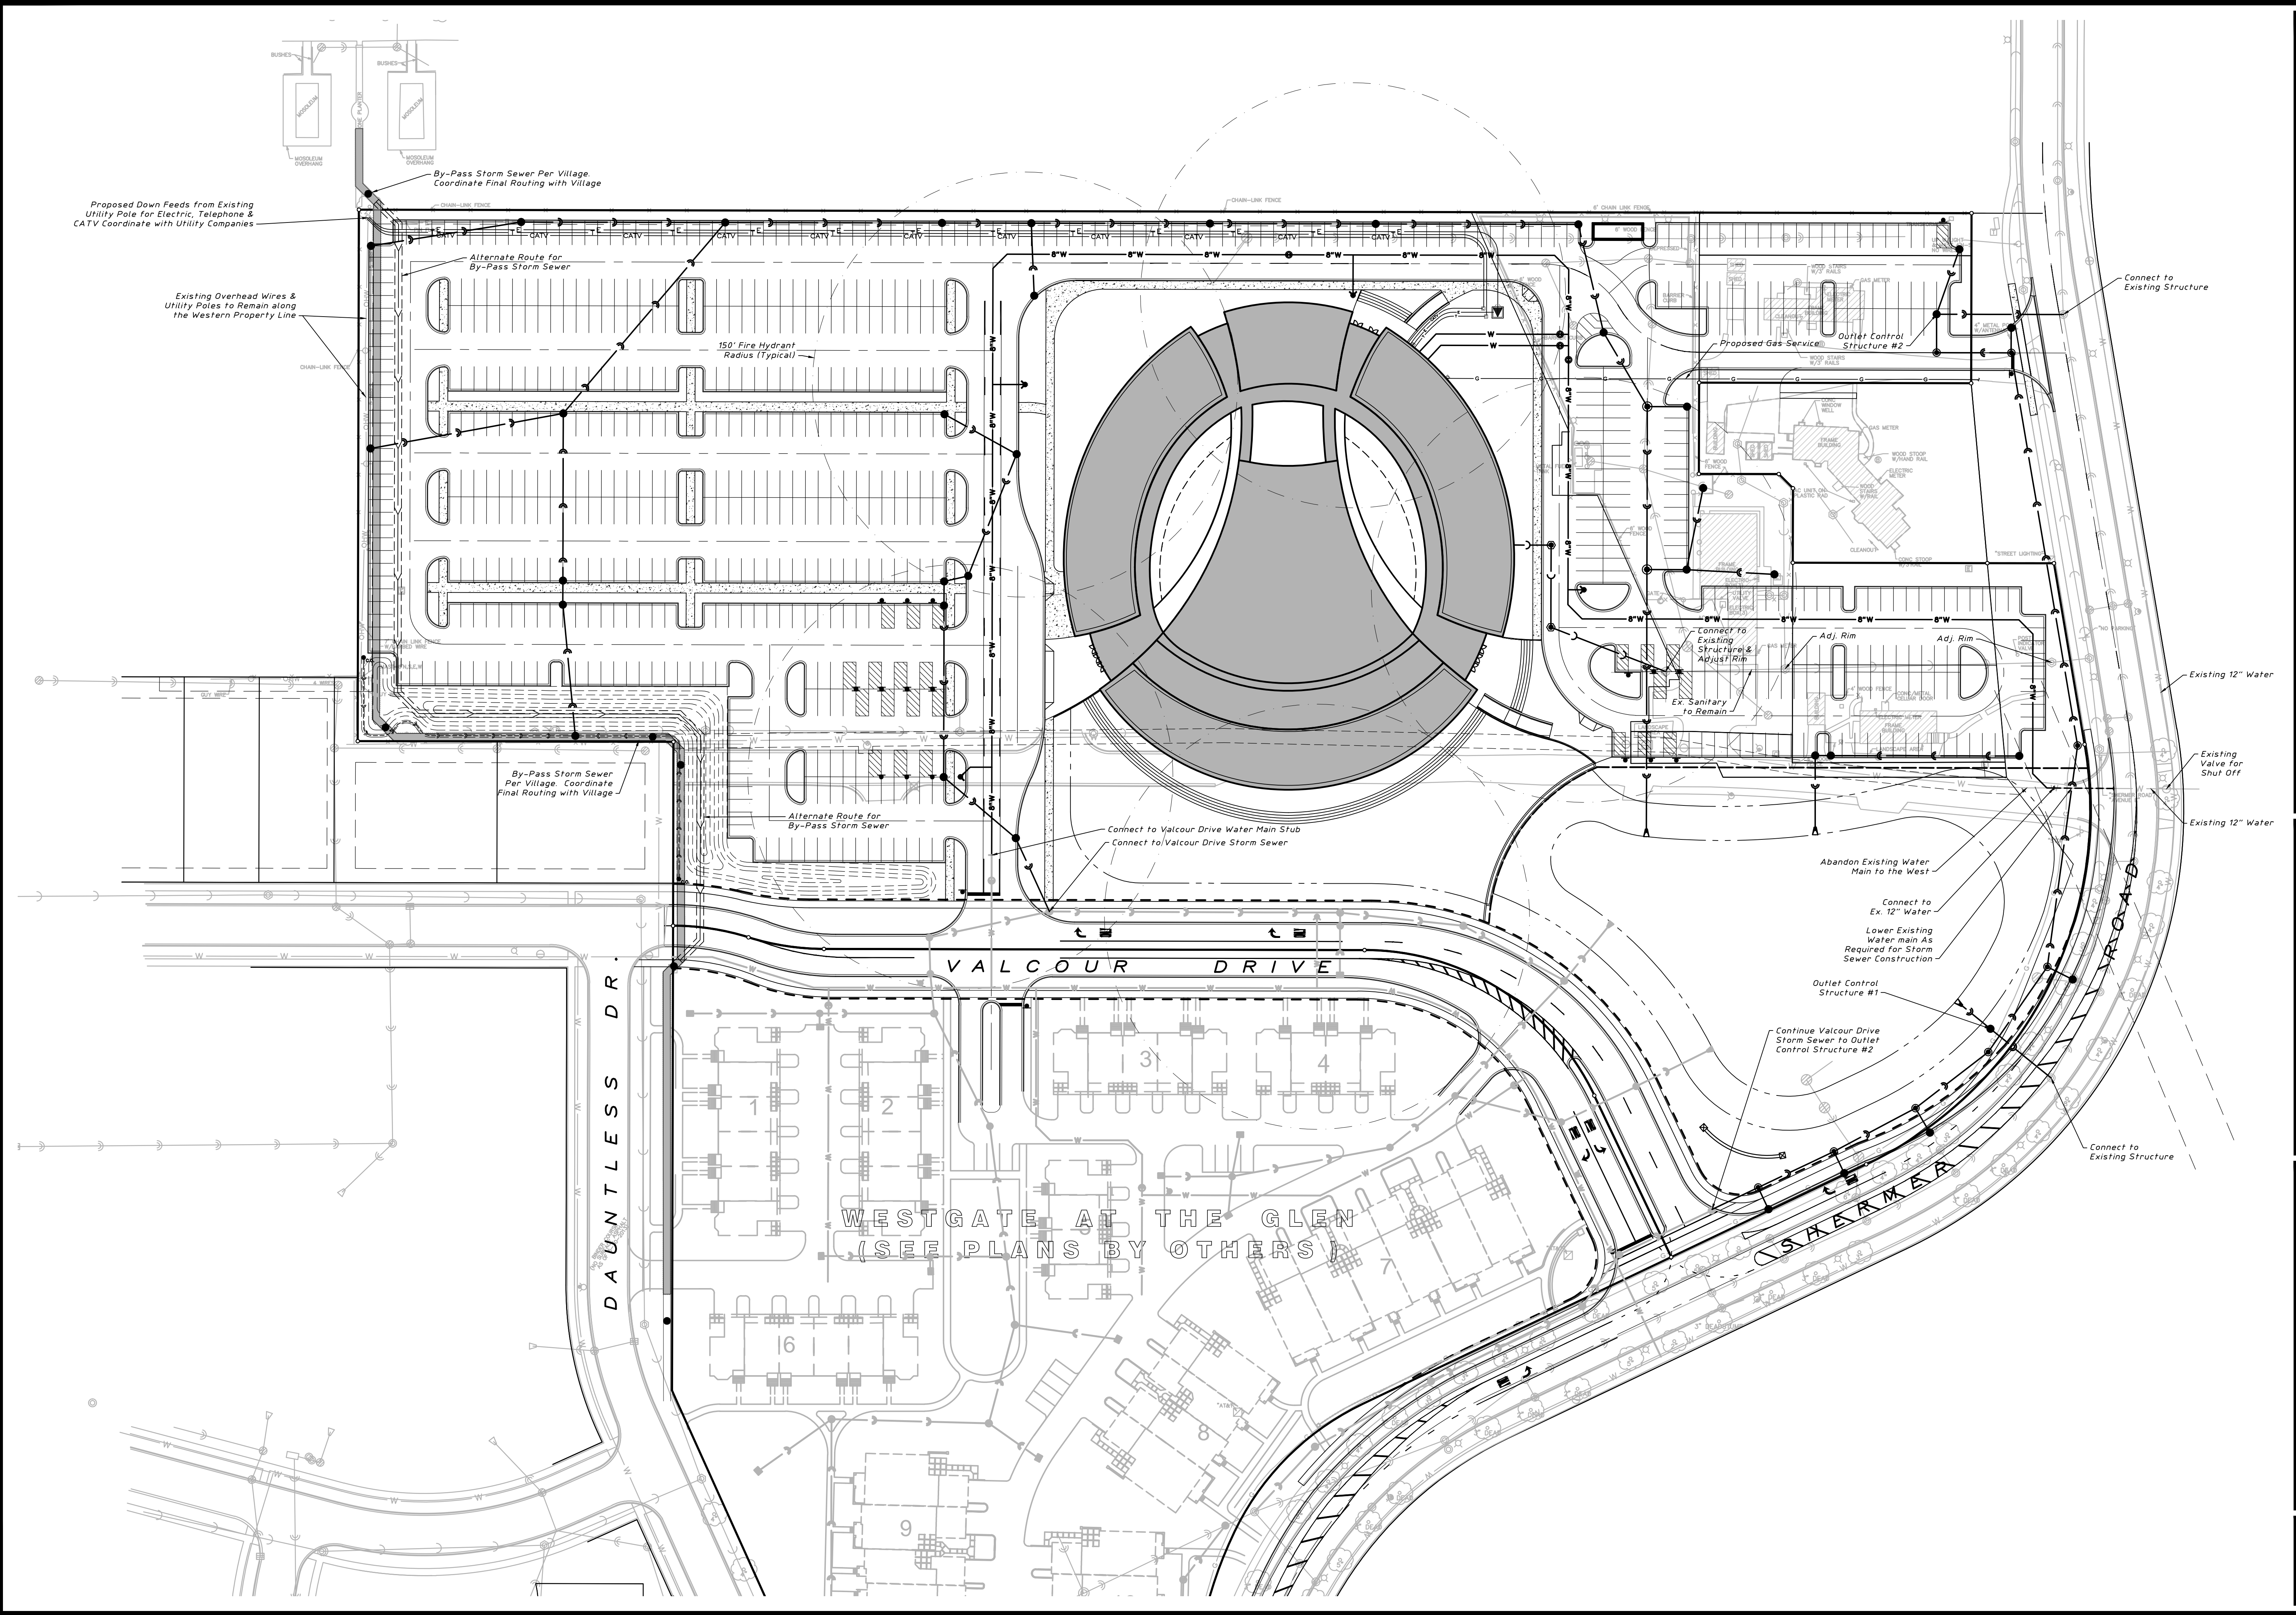


Revision	Date	No.

HAEGER ENGINEERING
 consulting engineers • land surveyors
 1304 N. Plum Grove Road, Schaumburg, IL 60173 • Tel: 847.394.6600 Fax: 847.394.6608
 Illinois Professional Design Firm License No. 184-003132
 www.haegerengineering.com

CONCEPT ENGINEERING
 UTILITY PLAN
WILLOW CREEK COMMUNITY
 CHURCH NORTH SHORE
 GLENVIEW, ILLINOIS

Project Manager: T A S
 Engineer: L A K
 Date: 09/20/2013
 Project No. 13012
 Sheet **CE.2** / CE.2

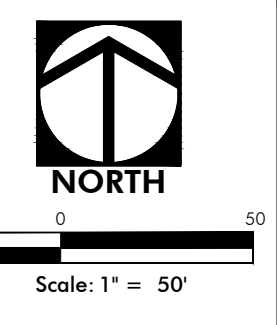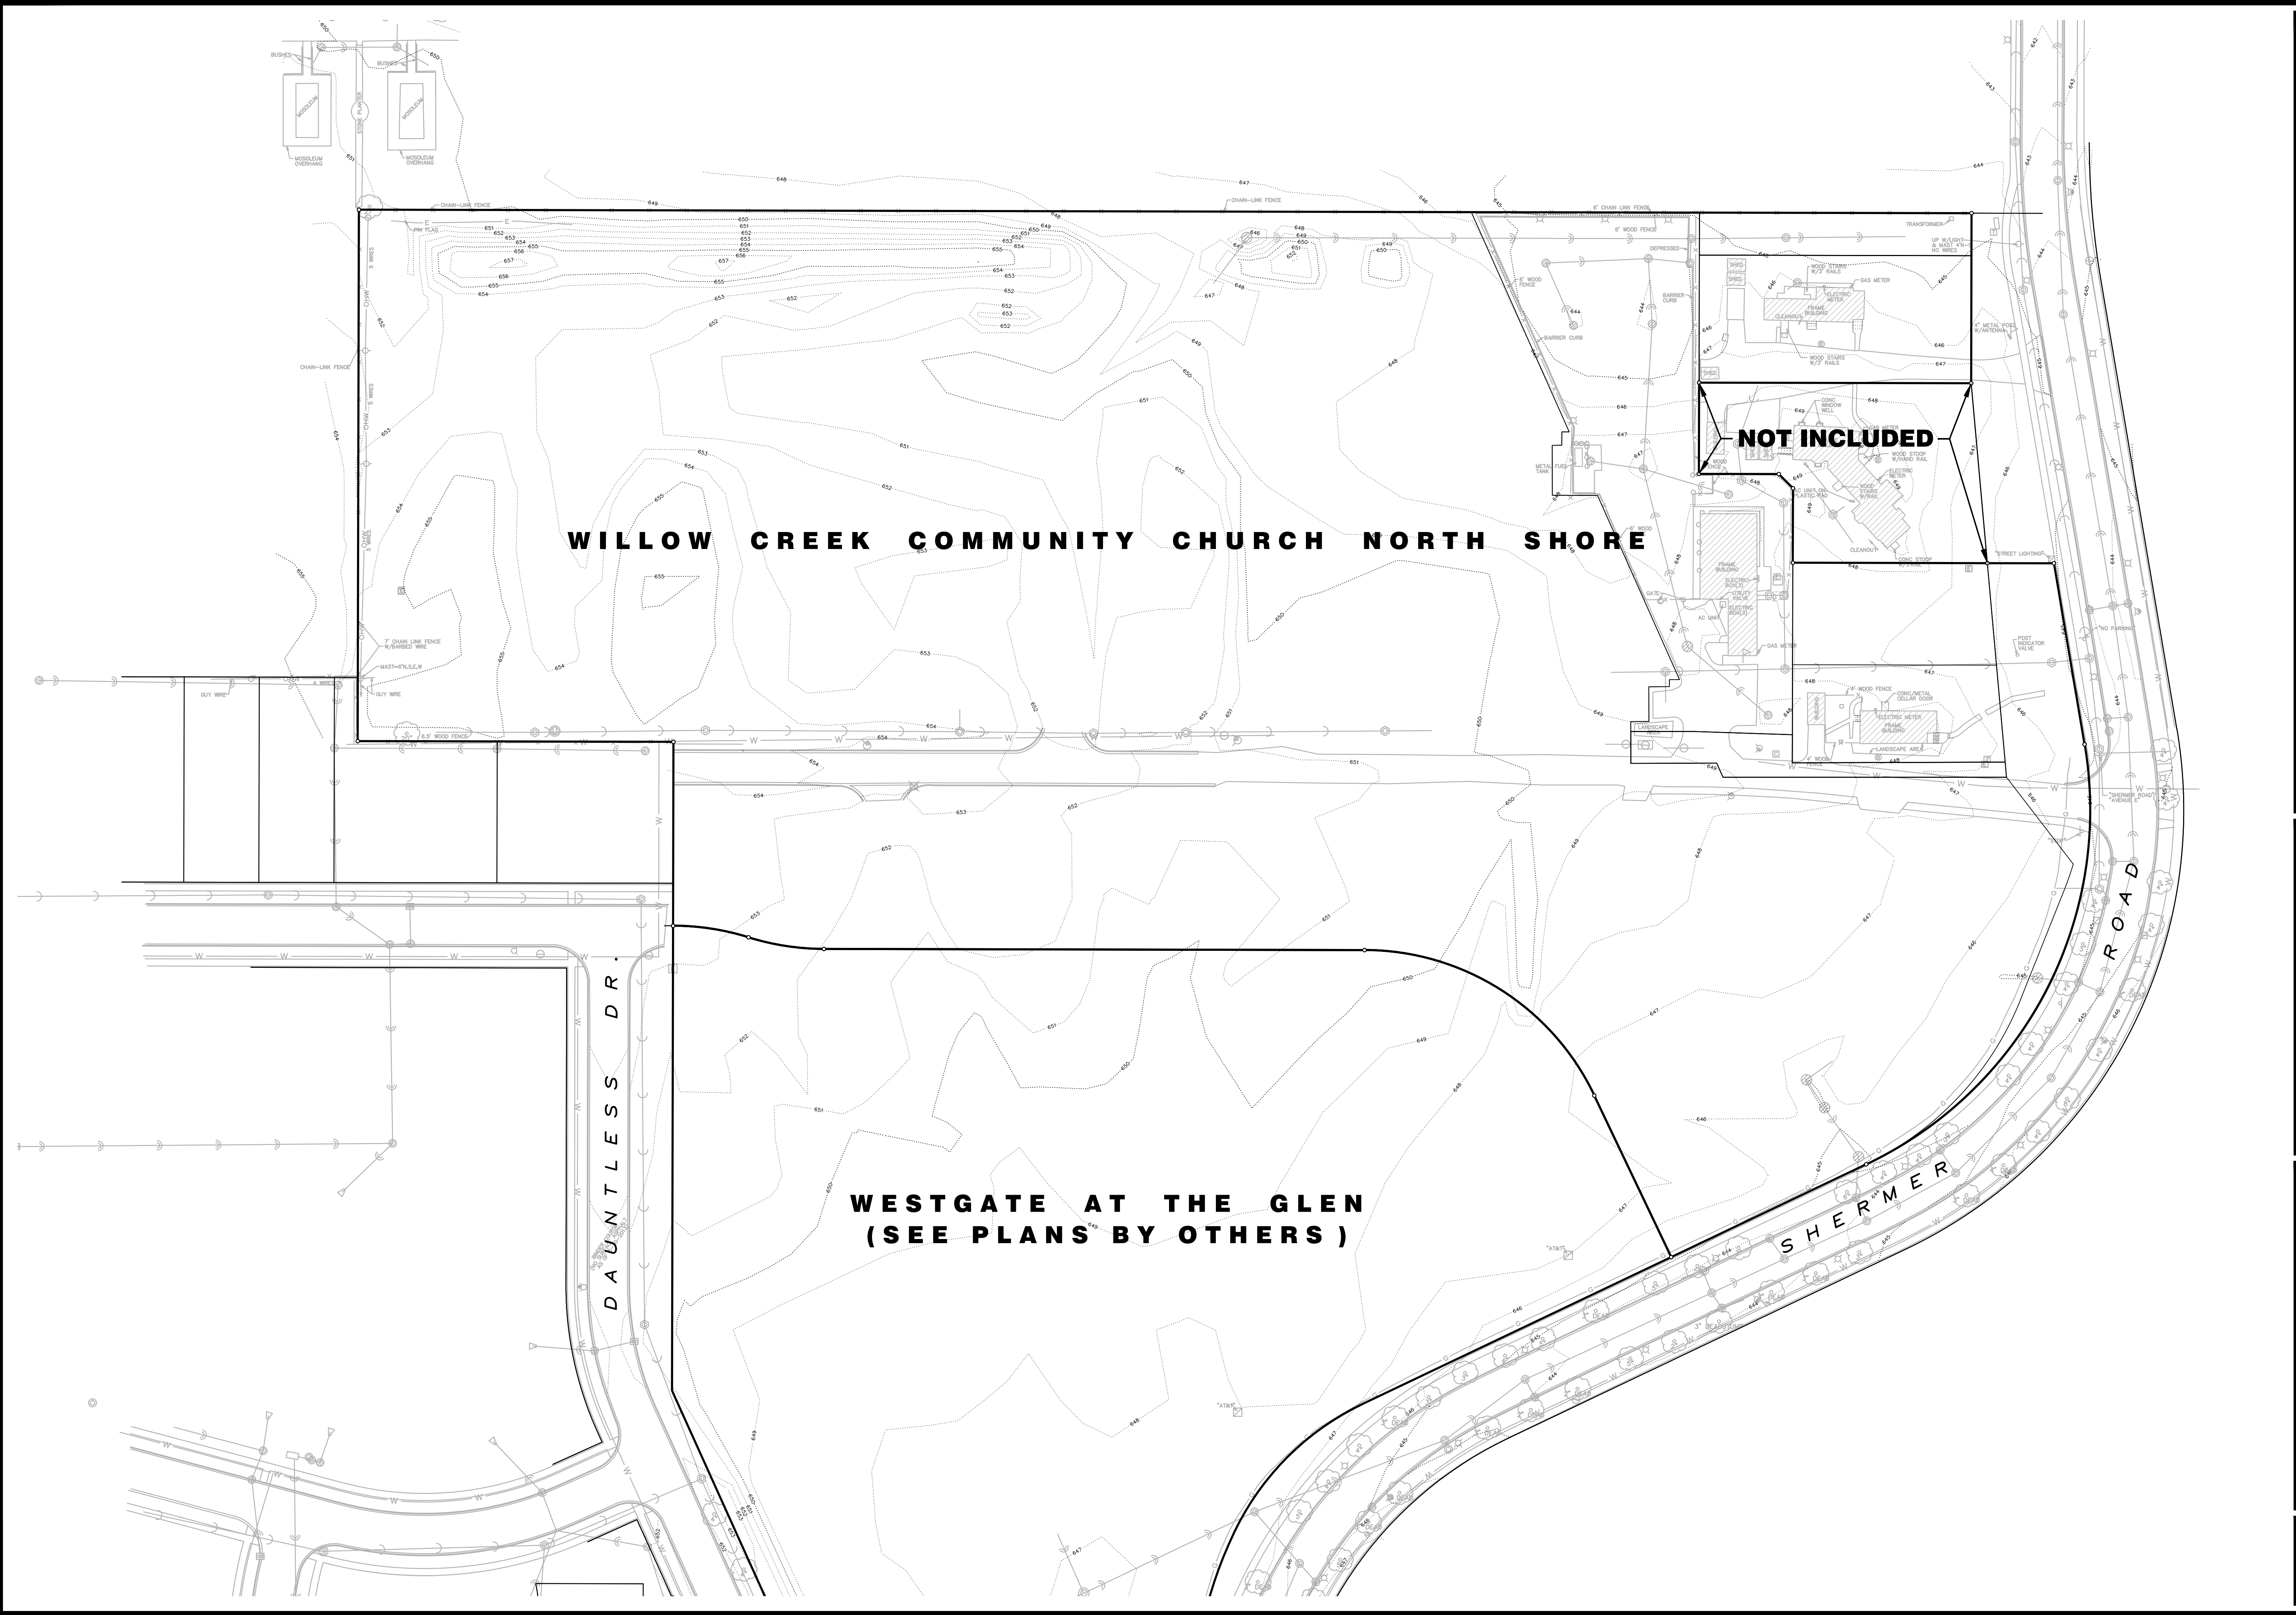

WILLOW CREEK COMMUNITY CHURCH NORTH SHORE

NOT INCLUDED

**WESTGATE AT THE GLEN
(SEE PLANS BY OTHERS)**

DAUNTLESS DR.

SHERMAN ROAD

SHERMAN

No.	Date	Revision

HAEGER ENGINEERING
 consulting engineers • land surveyors
 1304 N. Plum Grove Road, Schaumburg, IL 60173 • Tel: 847.394.6600 Fax: 847.394.6608
 Illinois Professional Design Firm License No. 184-003132
 www.haegerengineering.com

EXISTING CONDITIONS
WILLOW CREEK COMMUNITY CHURCH NORTH SHORE
 GLENVIEW, ILLINOIS

Project Manager: T A S
 Engineer: L A K
 Date: 09/20/2013
 Project No. 13012
 Sheet **EX.1** / EX.1